


SAFETY, HEALTH AND ENVIRONMENTAL INFORMATION	
IN ADDITION TO THE HAZARDS/RISKS NORMALLY ASSOCIATED WITH THE TYPES OF WORK DETAILED ON THIS DRAWING, NOTE THE FOLLOWING:	
HEALTH & SAFETY ▲	
HS/HS/001 - WORKS IN CLOSE PROXIMITY TO PUBLIC	C / M / D
HS/HS/002 - WORKING NEXT TO LIVE TRAFFIC	C / M / D
HS/HS/003 - WORKING NEXT TO STEEP EMBANKMENTS	C / M / D
HS/HS/004 - WORKING ON / NEXT TO EXISTING BRIDGE	C / M / D
HS/HS/005 - WORKING WITHIN EXISTING RIVER	C / M / D
HS/HS/006 - WORKING NEXT TO SMALL WATERCOURSE	C / M / D
HS/HS/007 - WORKING UNDER EXISTING OVERHEAD LINES	C / M / D
ENVIRONMENTAL ▲	
HS/SE/001 - WORKS IN CLOSE PROXIMITY TO EXISTING TREE ROOT PROTECTION ZONES	C / D
HS/SE/002 - VEGETATION CLEARANCE - POTENTIAL FOR HABITAT DISTURBANCE	C / D
HS/SE/003 - VEGETATION CLEARANCE - POTENTIAL FOR PROTECTED SPECIES	C / D
UTILITIES ▲	
HS/SU/001 - EXISTING UTILITIES	C / M / D
IT IS ASSUMED THAT ALL WORKS WILL BE CARRIED OUT BY A COMPETENT CONTRACTOR WORKING, WHERE APPROPRIATE, TO AN APPROVED METHOD STATEMENT, TO BE READ IN CONJUNCTION WITH RISK REGISTER FOR FURTHER INFORMATION AND MITIGATION MEASURES.	

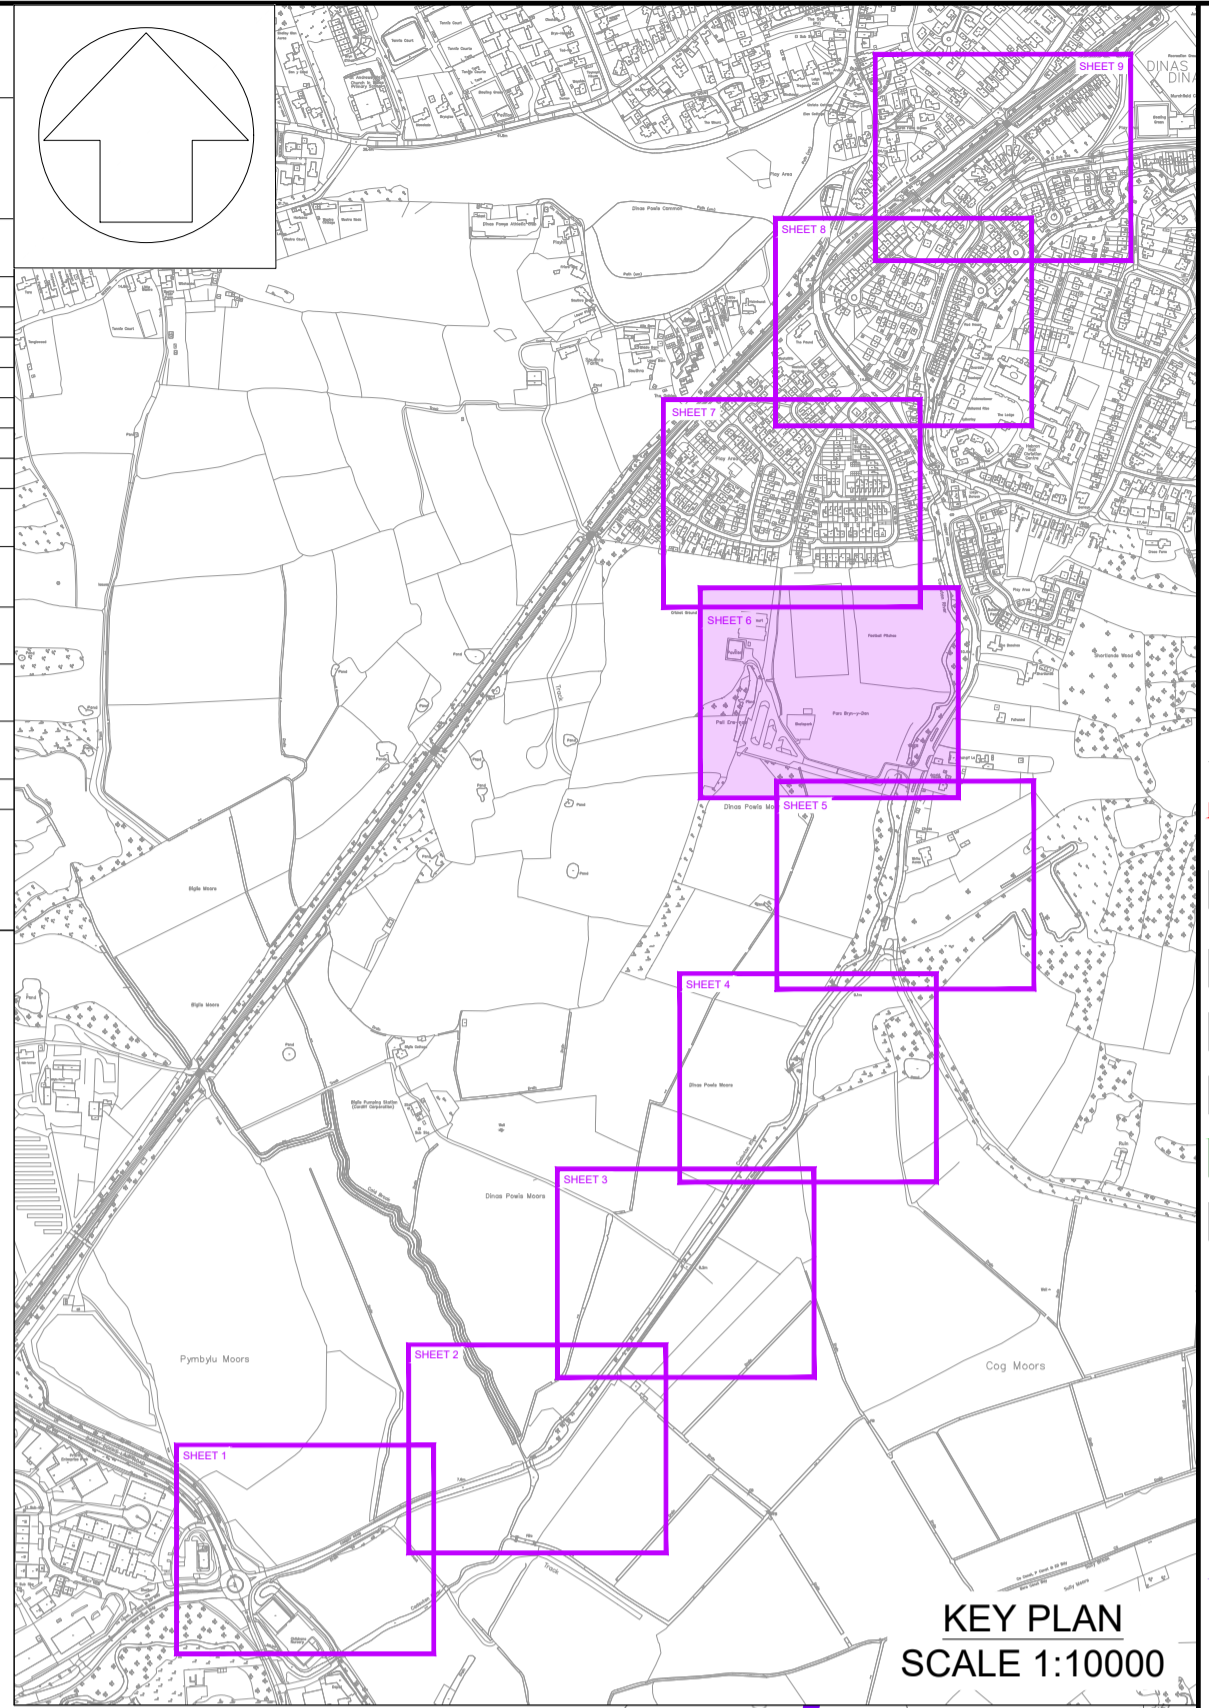

- NOTES**
- DO NOT SCALE FROM DRAWING. USE FIGURED DIMENSIONS ONLY.
 - ALL UNITS ARE IN METERS UNLESS STATED OTHERWISE.
 - REFER TO DRAWING 10058585-ARC-XX-010-DR-C-00004 FOR GENERAL ARRANGEMENT OVERVIEW.
 - REFER TO DRAWING 10058585-ARC-XX-010-DR-C-00019 FOR SITE LOCATION PLAN.
 - REFER TO DRAWING 10058585-ARC-XX-010-DR-C-00039-00040 FOR EXISTING SITE PLANS.
 - REFER TO DRAWING 10058585-ARC-XX-072-DR-C-00001 FOR TYPICAL CROSS SECTIONS.
 - REFER TO DRAWINGS 10058585-ARC-XX-130-DR-C-00001-00009 FOR PROPOSED STREET LIGHTING LAYOUTS.

KEY

	PLANNING BOUNDARY
	PROPOSED SHARED FOOTWAY/CYCLEWAY
	FOOTWAY
	CARRIAGEWAY
	PROPOSED VEHICLE CROSSOVER
	PROPOSED INDICATIVE EARTHWORKS
	PROPOSED RAISED TABLE
	PROPOSED BLISTER TACTILE PAVING
	PROPOSED LADDER TACTILE PAVING
	PROPOSED CONTROLLED CROSSING BLISTER TACTILE PAVING
	PROPOSED ROAD MARKINGS
	PUBLIC RIGHT OF WAYS

Rev	Date	Description	Prod.	Chk.	Rev.	App.
P01	11/11/24	FIRST ISSUE	GJ	SD	MG	MG

VALE OF GLAMORGAN
BRO MORGANWIG

Project: Biglis to Dinas Powys ATR

Site: Biglis to Dinas Powys Cardiff
Client: Vale of Glamorgan Council Civic Offices, Holton Rd, Barry CF83 4RU
www.valeofglamorgan.gov.uk

ARCADIS

Registered office: 80 Fenchurch Street, London EC3M 4BY
Coordinating office: Arcadis Suite 4d, 4th Floor, Hodge House, 144-166 St Mary St, Cardiff CF10 1DY
Tel: 44 (0)29 2092 6700
www.arcadis.com © Copyright reserved

Drawing Title: GENERAL ARRANGEMENT SHEET 6 OF 9

Designed: G.Jones	Signed: Digitally Signed	Date: 29/08/24
Produced: G.Jones	Signed: Digitally Signed	Date: 08/11/24
Checked: S.Davies	Signed: Digitally Signed	Date: 08/11/24
Reviewed: M.Griffiths	Signed: Digitally Signed	Date: 11/11/24
Approved: M.Griffiths	Signed: Digitally Signed	Date: 11/11/24

Design Stage: Preliminary Design

Original Size: A1 Grid: OS Datum: ODN

Suitability Code: S1 Scale: 1:500 Project Number: 10058585

Suitability Description: Suitable for Coordination

Drawing Number: 10058585 - ARC - XX - 010 - DR - C - 00010 Revision: P01